


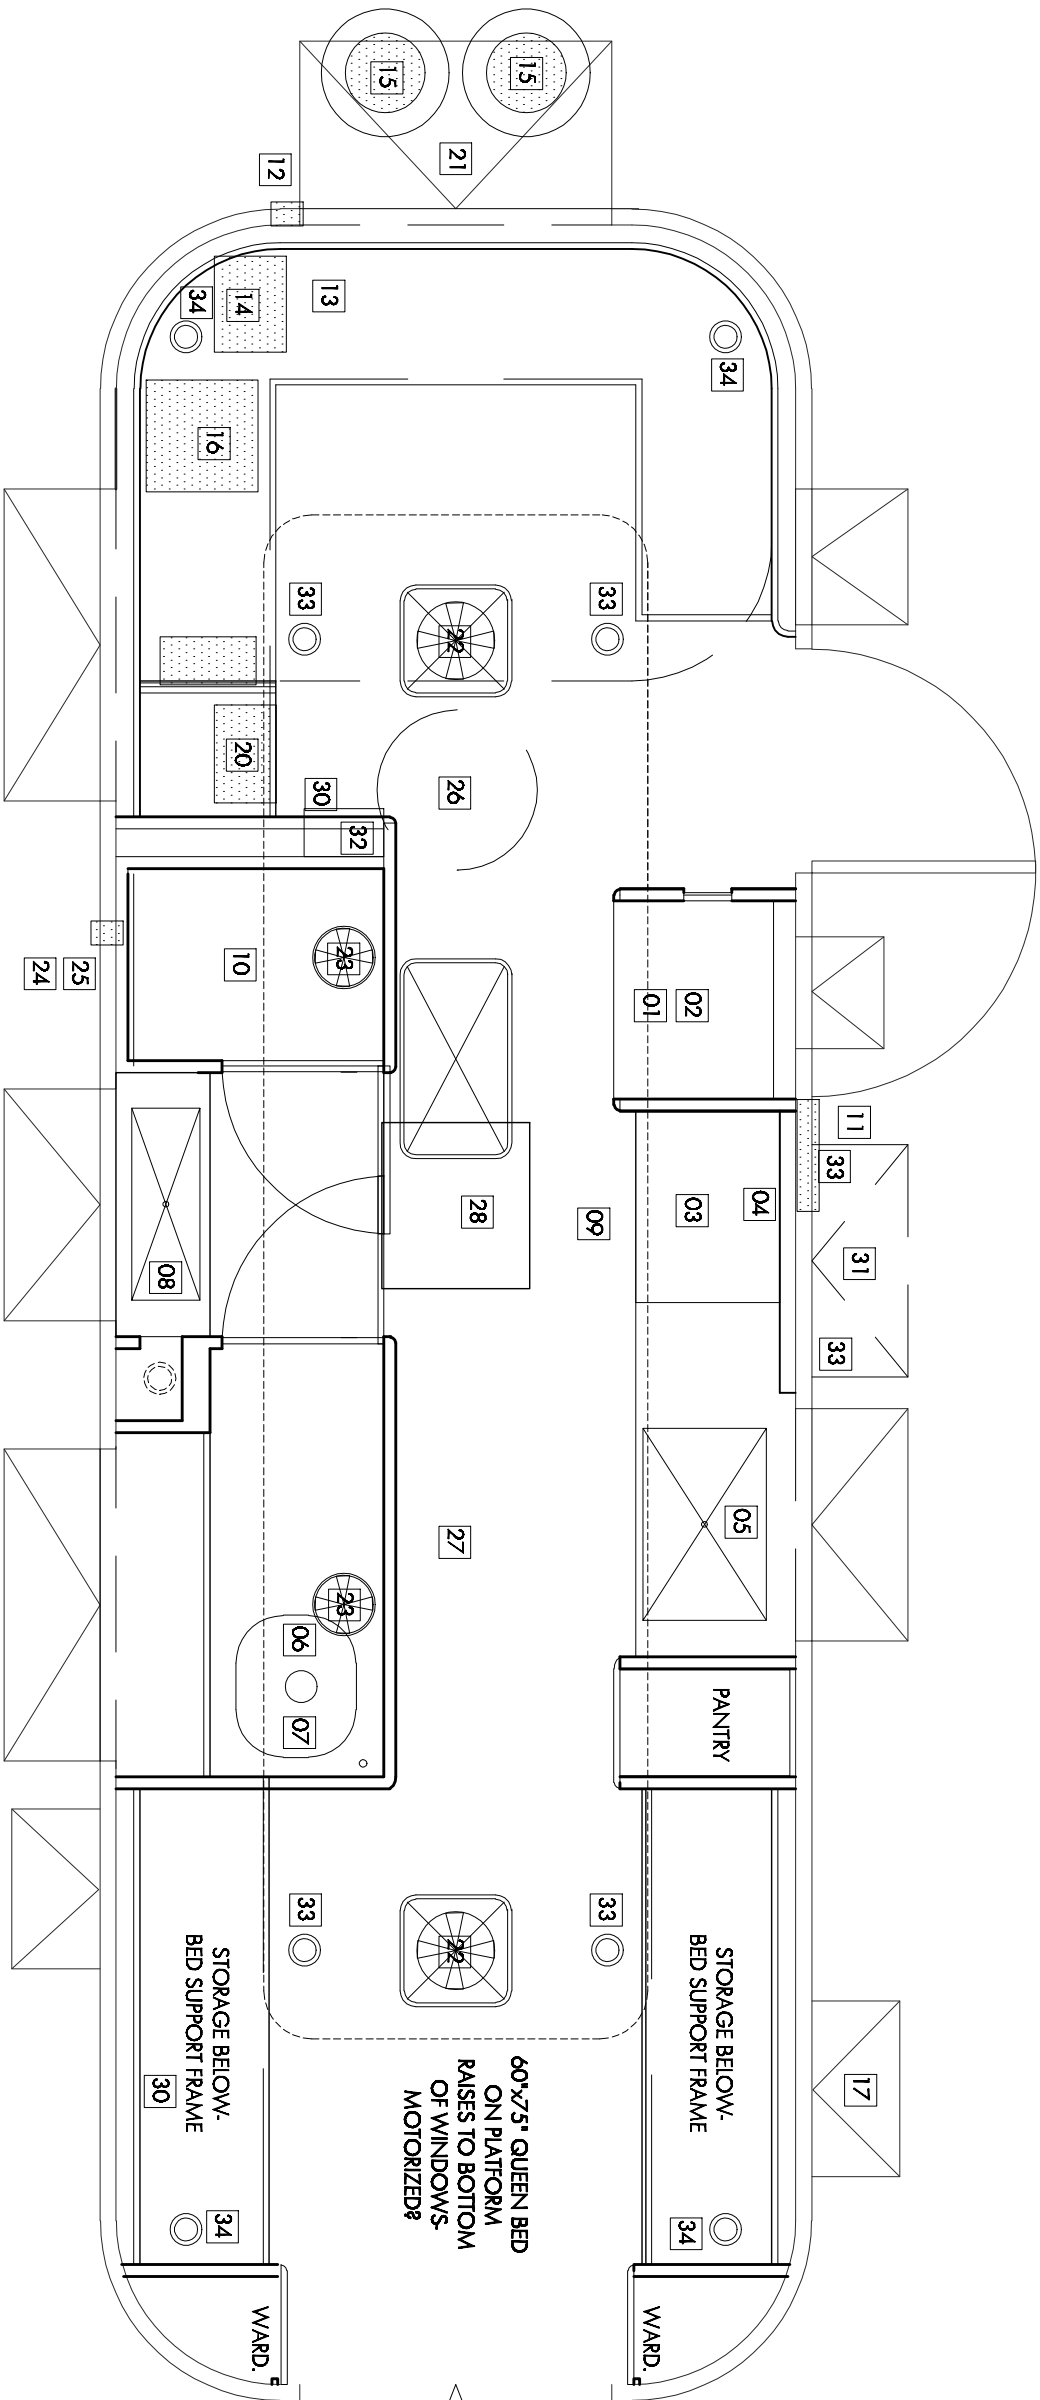

- 01

Domestic Refrigerator
- 02

Microwave
- 03

Alwood Range
- 04

Kitchen Hood
- 05

Kitchen Sink
- 06

Toilet
- 07

Black Tank
- 08

Vanity Sink
- 09

Grey Tank
- 10

Shower
- 11

Outdoor Shower
- 12

Water Inlet
- 13

Fresh Water Tank-39" LX18" WX
- 14

Water Pump
- 15

30# Alum. Propane Tanks
- 16

On Demand Propane HW
- 17

Future Propane St.Stl.Grille
- 18

-
- 19

-
- 20

PD 4060-60 Amp Converter
- 21

Battery
- 22

Fan-Tastic 6000RBT/A
- 23

12V Roof Vent
- 24

Marinco 30amp Inlet
- 25

Marinco CATV Inlet
- 26

Future Satellite
- 27

Future Solar Array
- 28

-
- 29

-
- 30

Interior TV
- 31

Exterior TV
- 32

Stereo
- 33

Interior Speaker(s)
- 34

UnderFloor Speaker(s)

FLOOR PLAN-Systems

SCALE 1/2" = 1'-0"



2115 Anchor Dr., SUITE C
SAN ANTONIO, TEXAS 78213
V. 210.738.2240 E. jms@jmsarchitects.com
www.jmsarchitects.com